
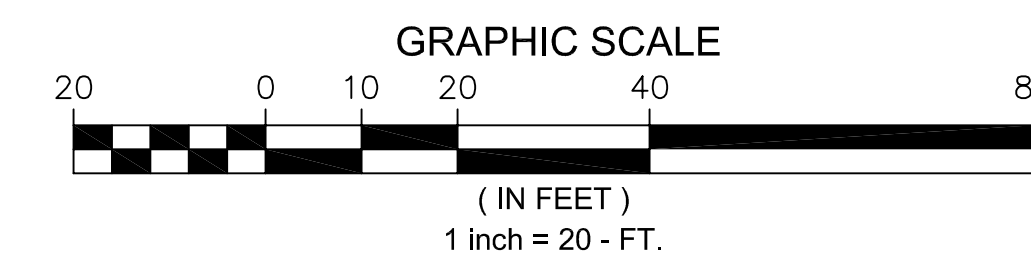


Luminaire Schedule							
Symbol	Qty	Label	Mounting Height	LLF	Lum. Lumens	Lum. Watts	Description
	7	A4	10' - 0" AFG	0.900	8822	70	ASL1-160L-70-3K7-4W-BC
	1	S4	15' - 0" AFG	0.900	8822	70	ASL1-160L-70-3K7-4W-BC

Calculation Summary							
Label	CalcType	Units	Avg	Max	Min	Avg/Min	Max/Min
Overall Area	Illuminance	Fc	0.16	11.3	0.0	N.A.	N.A.
Parking Area	Illuminance	Fc	1.73	11.3	0.0	N.A.	N.A.

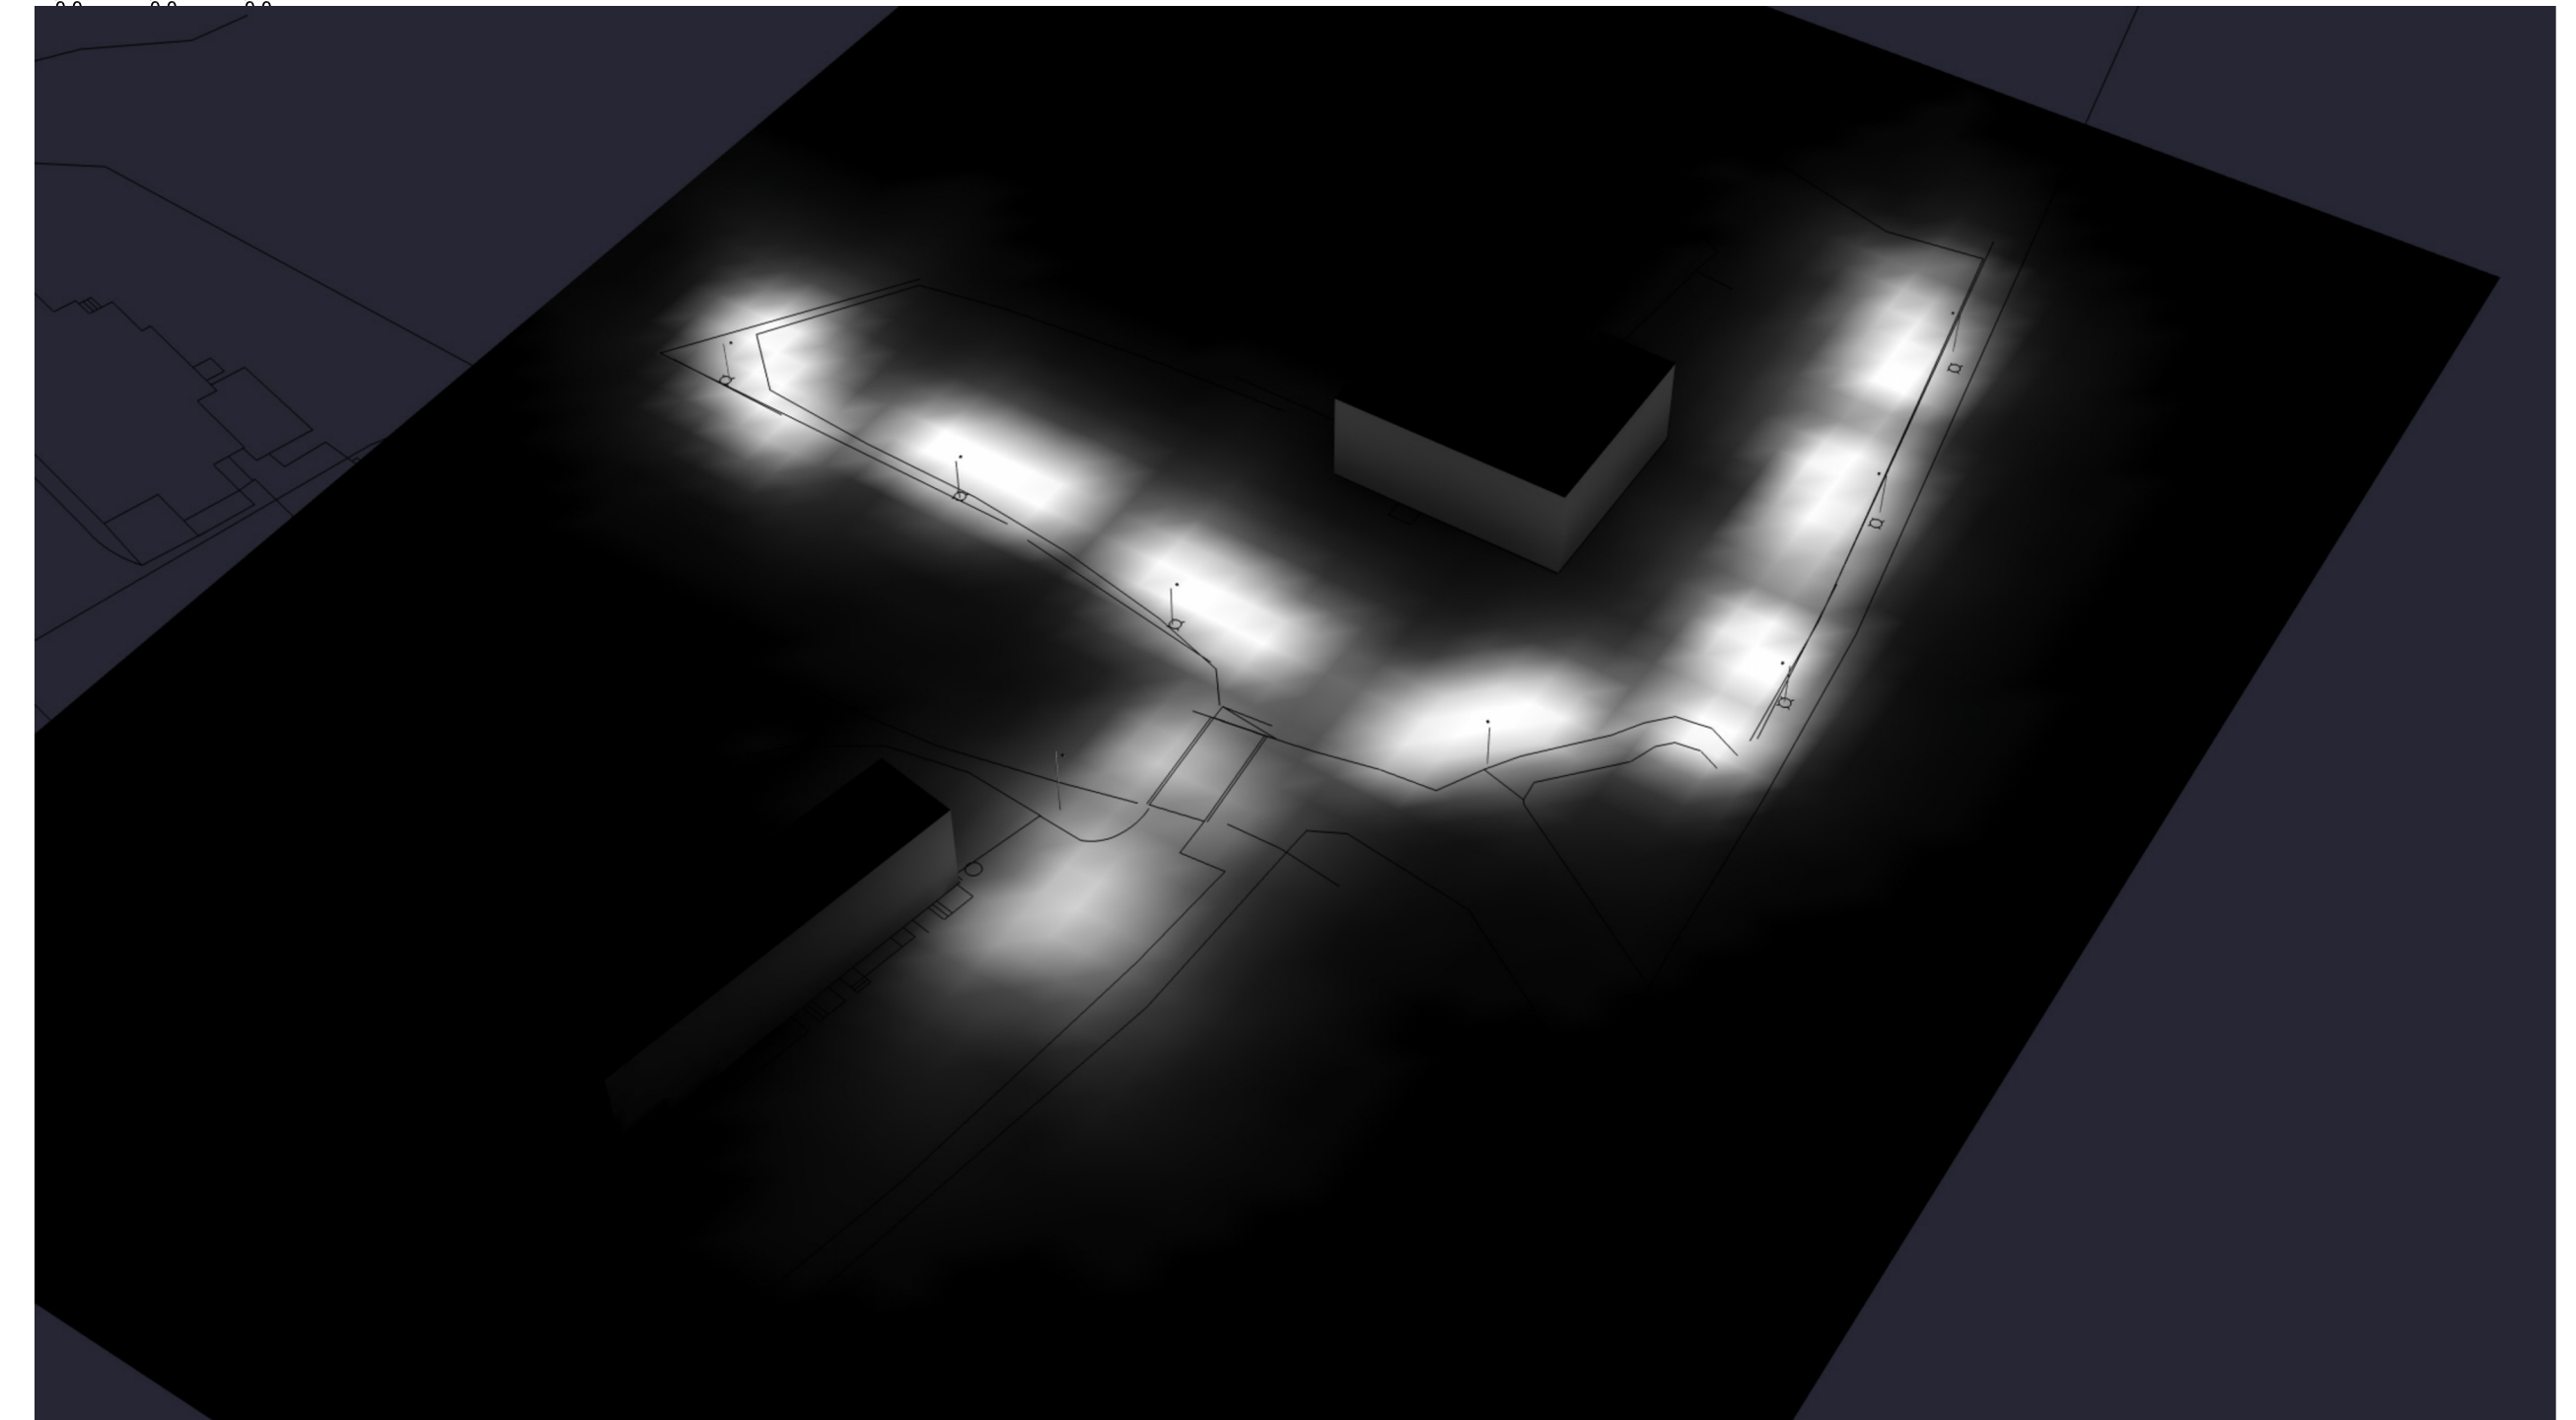

Project: White Horse	
Contact: Cliff Gilbert Specifications - Southern CT (203) 788-0814 cgilbert@illuminatene.com	Detail: Photometric Calculation Date: 5/9/2023 Revision: 3 Scale: 1" = 20'-0" Drawn By: MFG
<b>illuminatene</b> 263 Winn Street Burlington, MA 01803 (781) 935-8500 333 Pleasant Valley Road South Windsor, CT 06074 (860) 282-0597	
Drawing Number:  <b>L-1</b>	
Sheet 1 of 1	